




FRONT VIEW

LEFT VIEW

ELEVATION VIEWS

SCALE: 1/8" = 1'
 28X52E17 DWG
 103/15/191

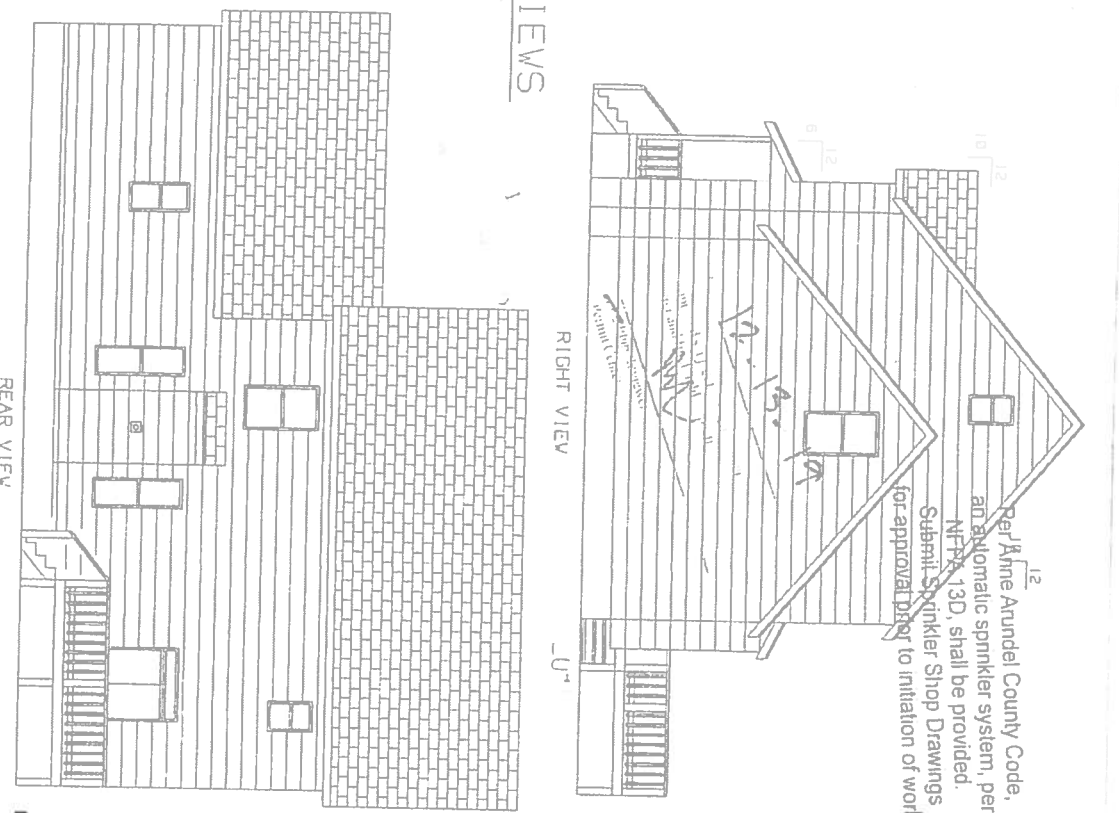


RIGHT VIEW

REAR VIEW


Per Maine Arundel County Code,
 an automatic sprinkler system, per
 NFPA 13D, shall be provided.
 Submit Sprinkler Shop Drawings
 for approval prior to initiation of work.

102378410 INSD

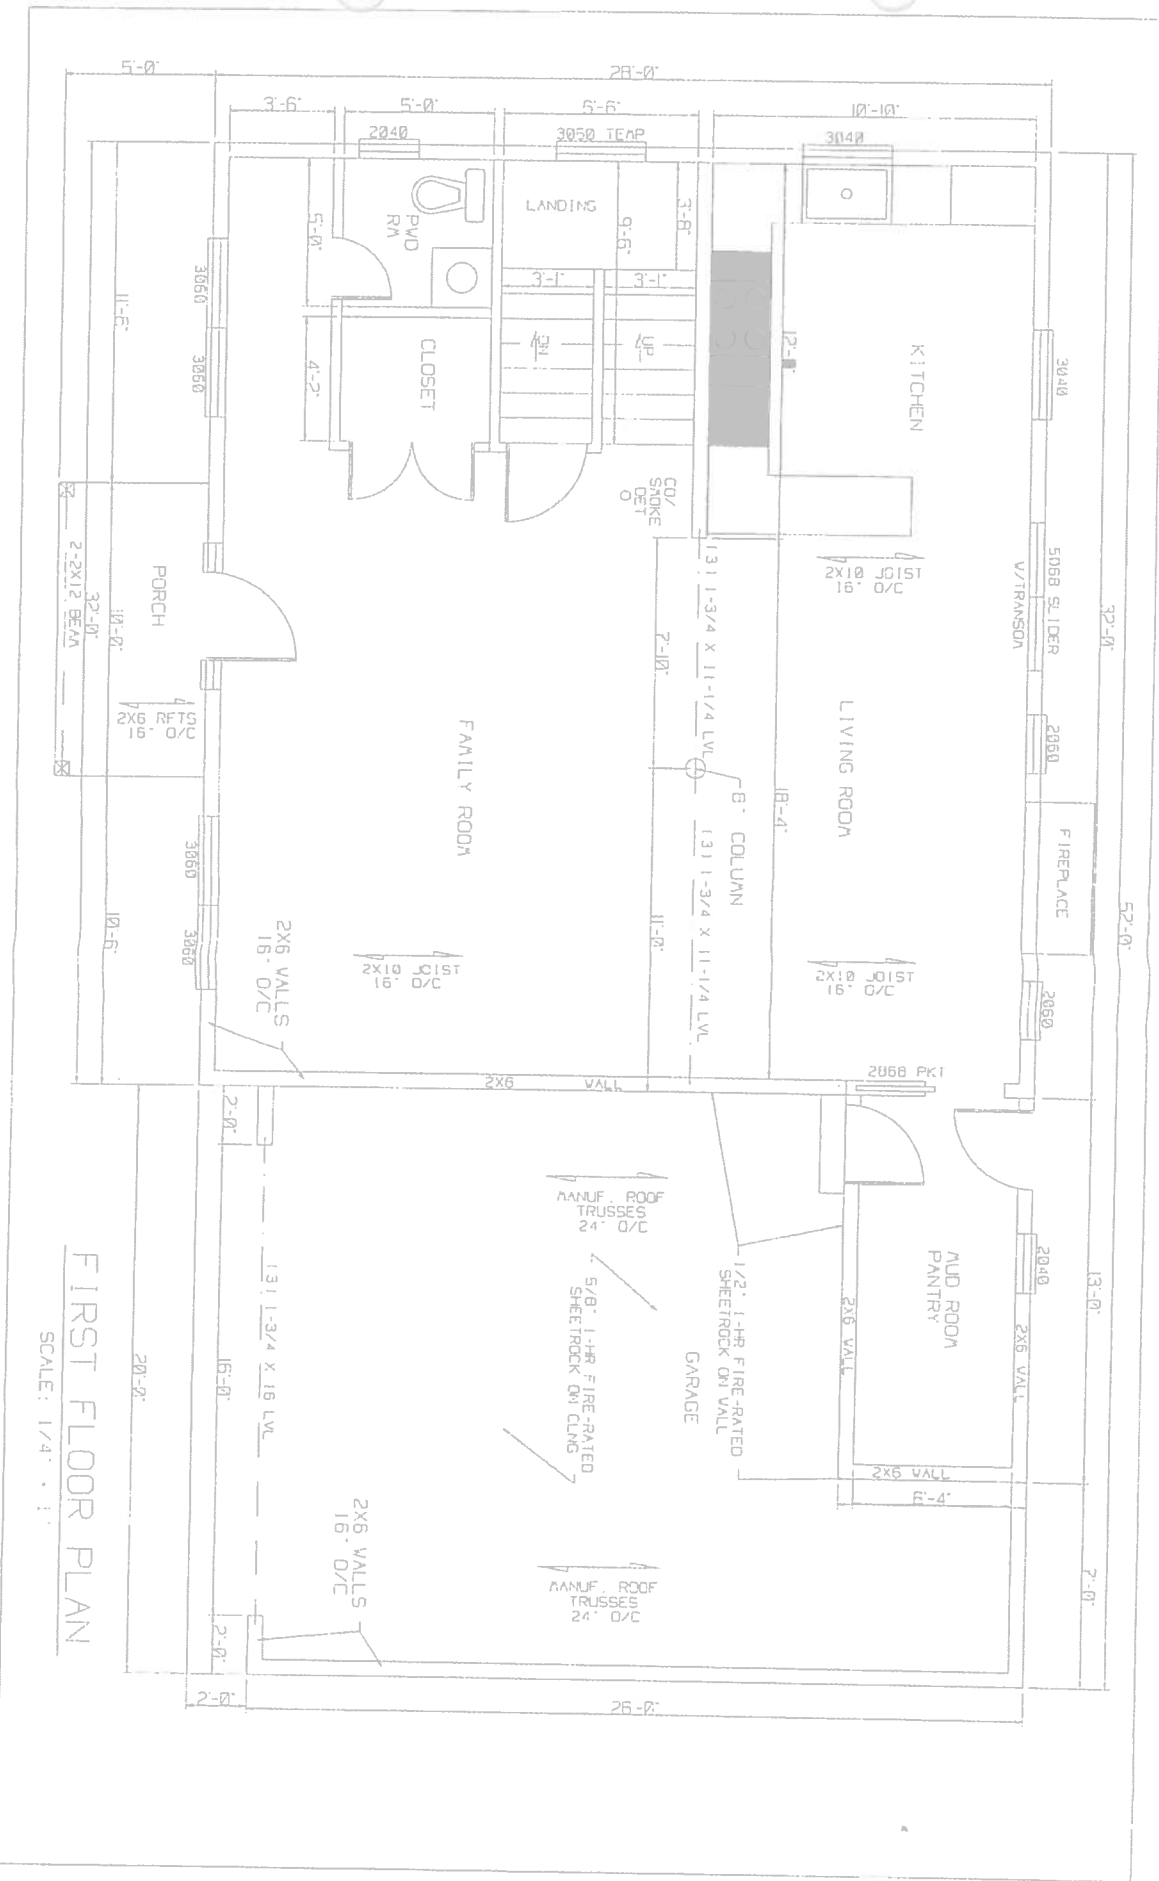


FIRST FLOOR PLAN

SCALE: 1/4" = 1'

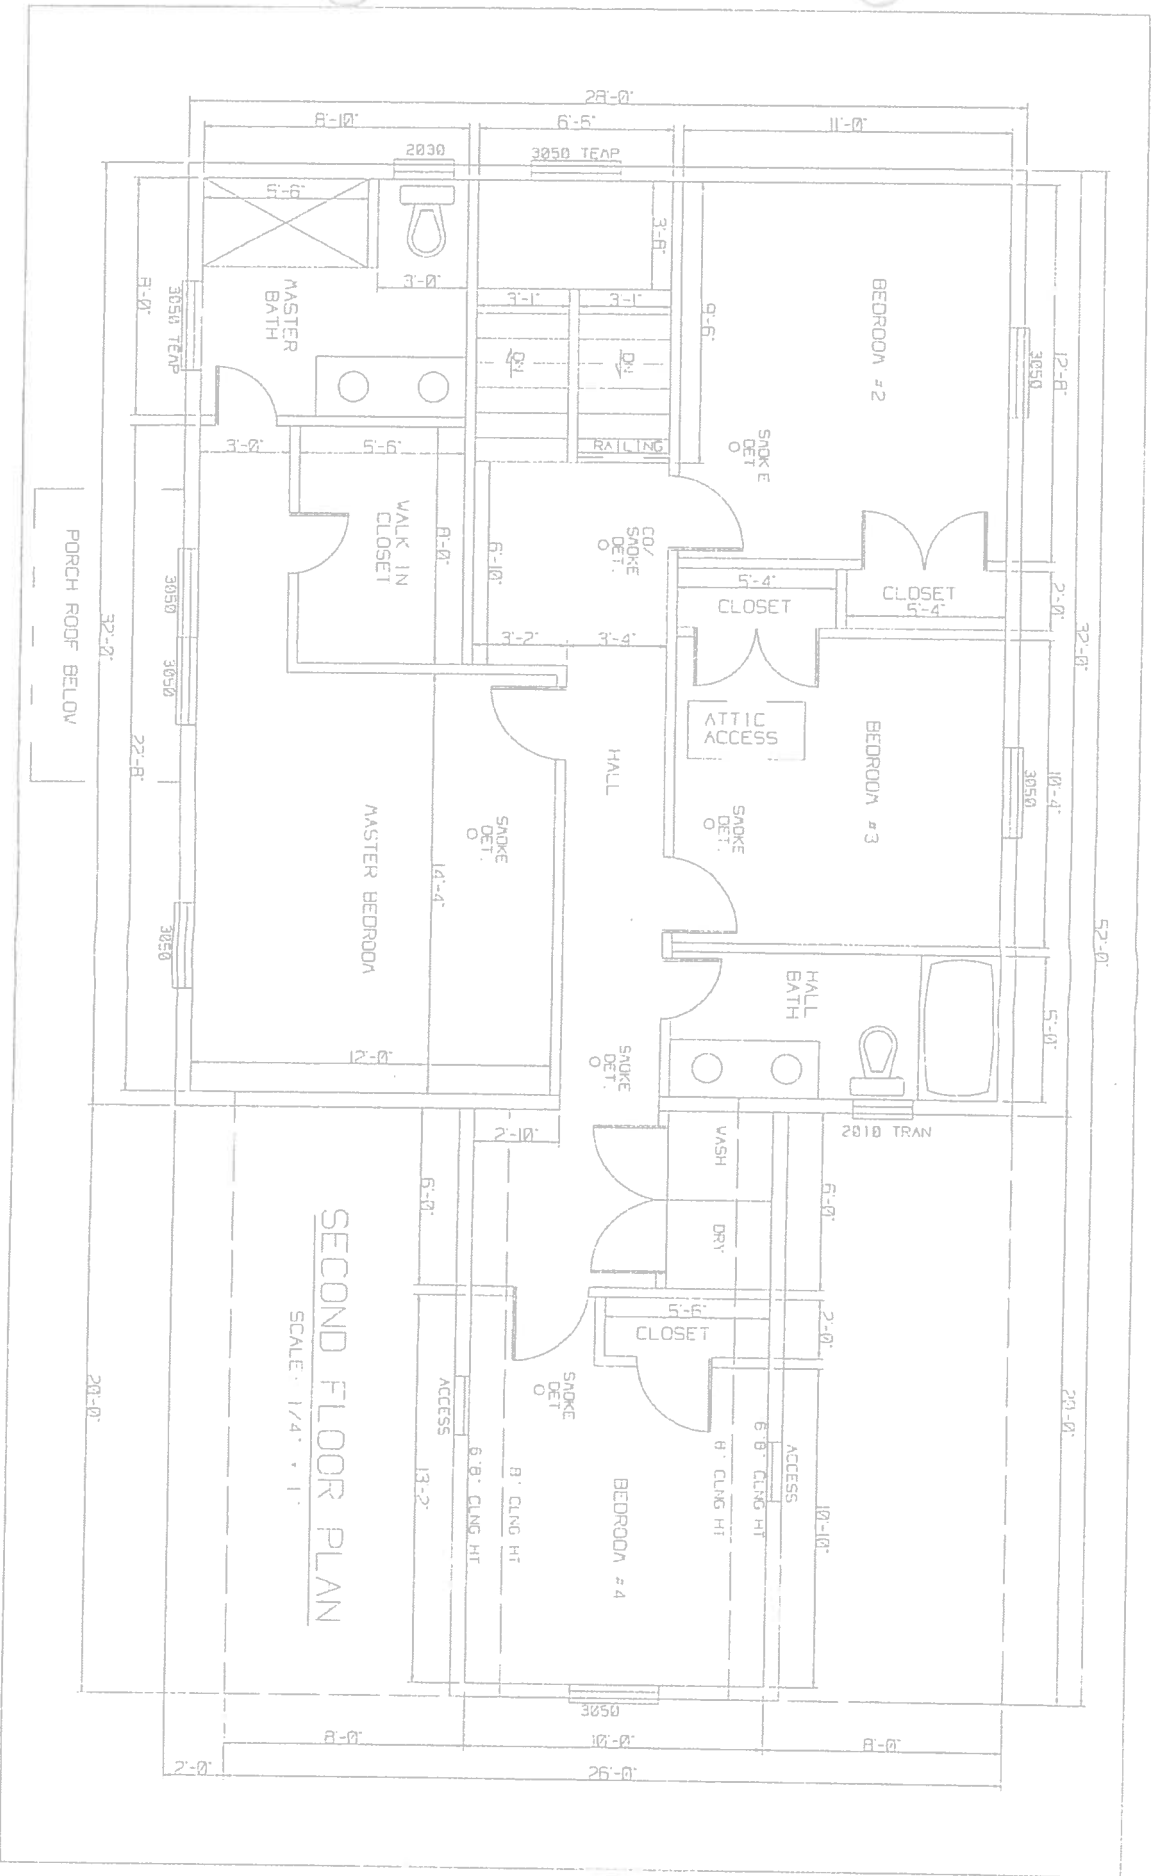

SECOND FLOOR PLAN

SCALE: 1/4" = 1'

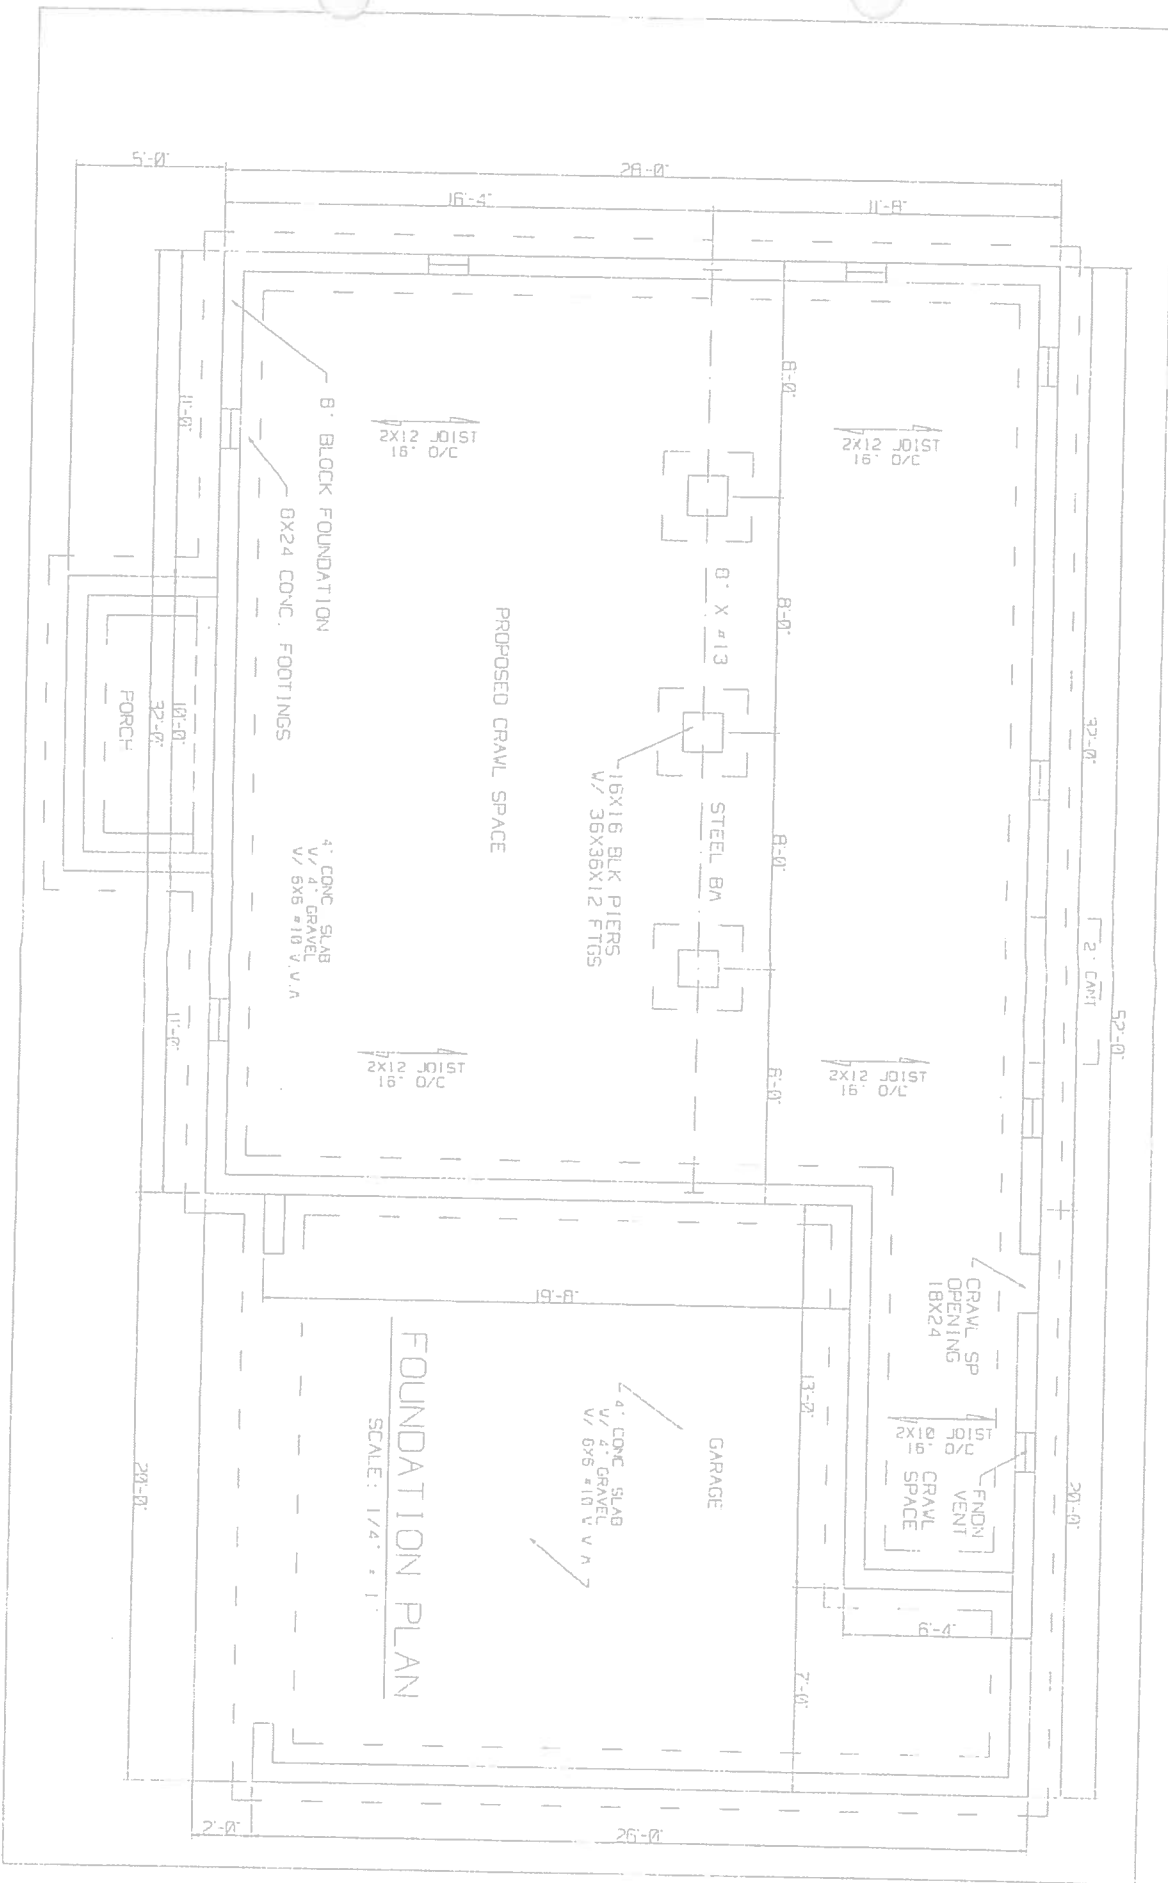

FOUNDATION PLAN

SCALE: 1/4" = 1'

8' BLOCK FOUNDATION
 8X24 CONC. FOOTINGS

4' CONC. SLAB
 V/ 2" GRAVEL
 V/ 6X6 #10 V.V.A.

PROPOSED CRAWL SPACE

STEEL BR
 15X16 BLK PIERS
 V/ 36X36X12 FTGS

GARAGE

4' CONC. SLAB
 V/ 2" GRAVEL
 V/ 6X6 #10 V.V.A.

FORCH

CRAWL SP
 OPENING
 18X24

FNDN
 VENT
 8" GRAV
 SPACE

5'-0"

26'-0"

16'-4"

11'-8"

11'-0"

8'-0"

2X12 JOIST
 2/0 21X2

8' X 4 1/2"

8'-0"

2X12 JOIST
 2/0 21X2

8'-0"

8'-0"

2X12 JOIST
 2/0 21X2

2X12 JOIST
 2/0 21X2

11'-0"

32'-0"

2' CMT

52'-0"

19'-8"

13'-2"

20'-0"

7'-0"

20'-0"

2'-0"

26'-0"